


Drawings For

BOYD LAKE WATER TREATMENT PLANT PAC SILO & TRANSFER SYSTEM CITY OF GREELEY, COLORADO

JULY, 2009

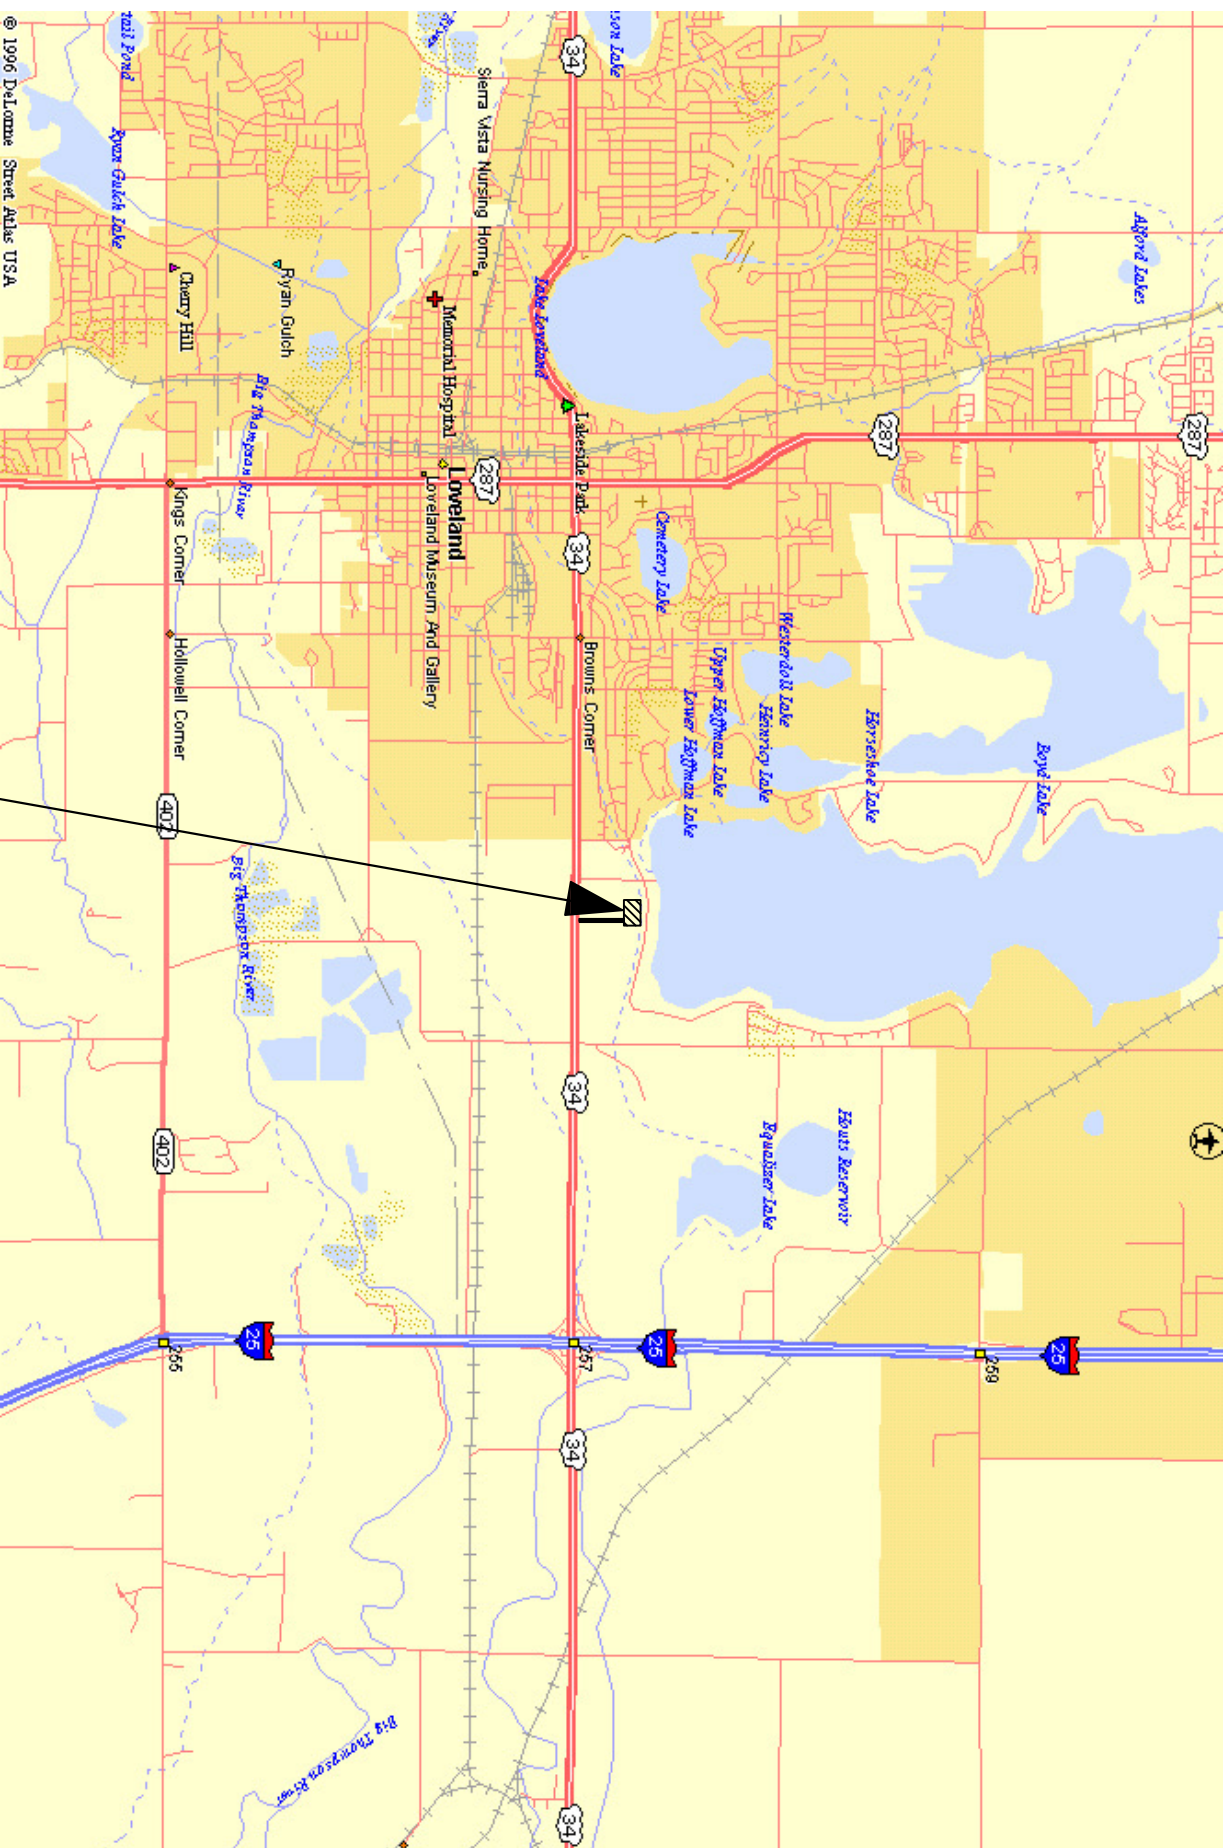

Project
Location



Index of Sheets

Description	Sheet
Cover Sheet	1
Site Plan	2
Foundation Plan	S3
Sections & Details	4
Electrical One-line Diagrams & Details	5
Electrical Schedules	6

REVISIONS	BY	DATE

DRAWN BY:	
CHECKED BY:	
SCALE:	
DATE:	JULY, 09
SHEETS	6
SHEET	1